


68'  
30'

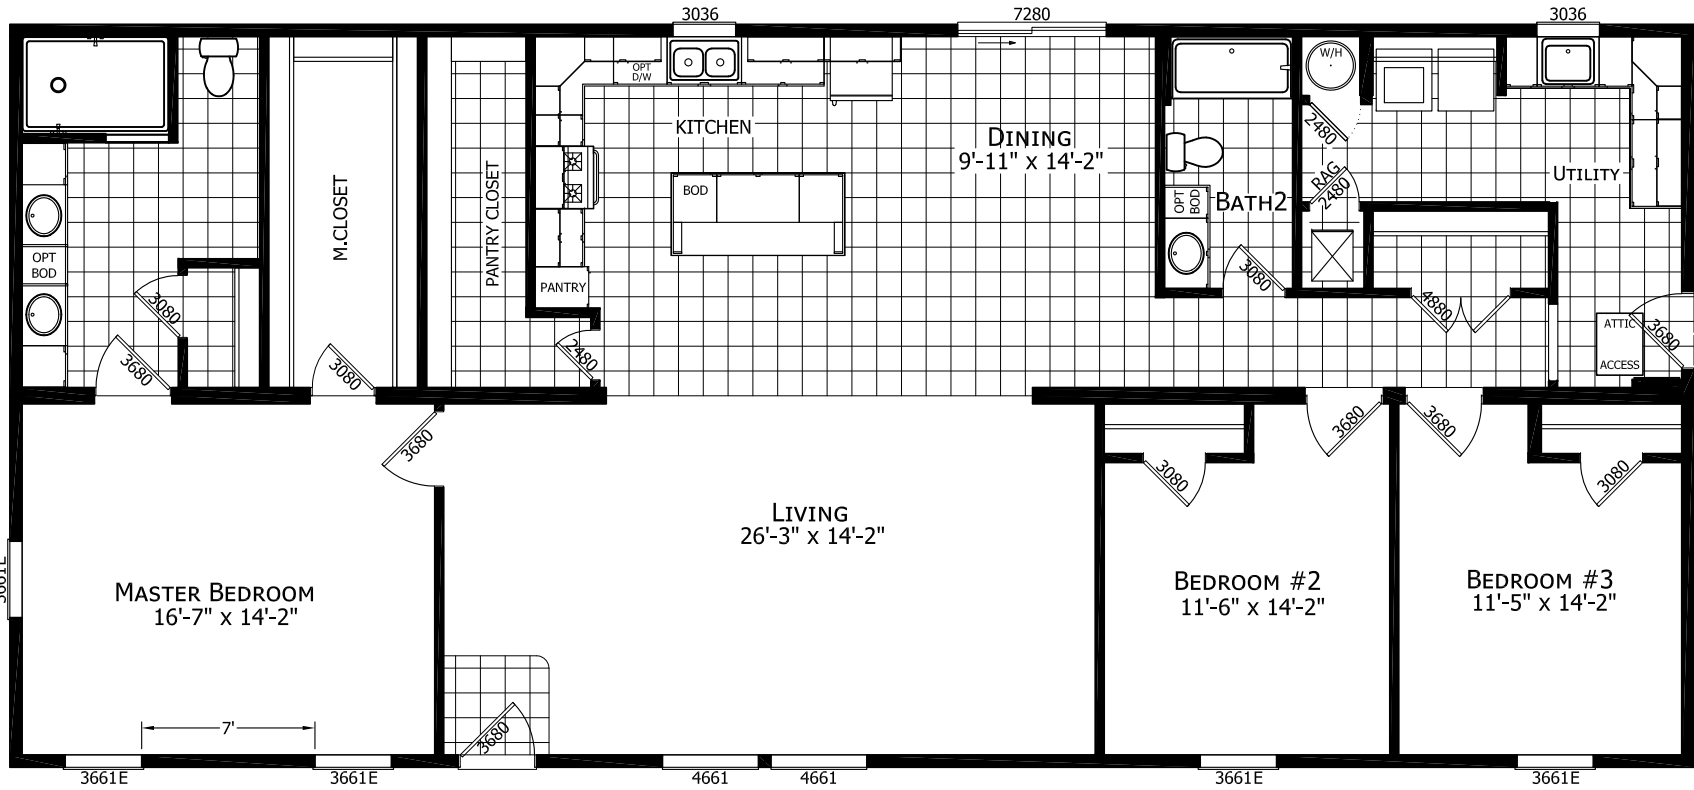

CUSTOMER SIGNATURE \_\_\_\_\_ (REV VERSION) \_\_\_\_\_ DATE \_\_\_\_\_

PHYSICAL SITE ADDRESS (OR CROSS ROADS) \_\_\_\_\_

CITY \_\_\_\_\_ STATE \_\_\_\_\_ ZIP \_\_\_\_\_

QUOTE \_\_\_\_\_ ESTIMATED SHIPPING DATE \_\_\_\_\_

MODIFICATIONS

PROJECT: HSM 683A  
32 x 68 3 BD 2 BTH  
EAST SIDE MILLER

DRAWN BY: SKYLAR HIERONIMUS  
DATE: 04-12-21  
SCALE: 3/16" = 1'-0"

TITLE: FLOOR PLAN  
ELECTRICAL PLAN

FILENAME: MILLER (HSM 683A)

SHEET: BROCHURE

PROPRIETARY AND CONFIDENTIAL  
THESE DRAWINGS AND SPECIFICATIONS ARE ORIGINAL,  
PROPRIETARY AND CONFIDENTIAL MATERIALS OF CHAMPION,  
COPYRIGHT © 1976-2021 BY CHAMPION



1600 ROWE AVE. WORTHINGTON, MN 56187